


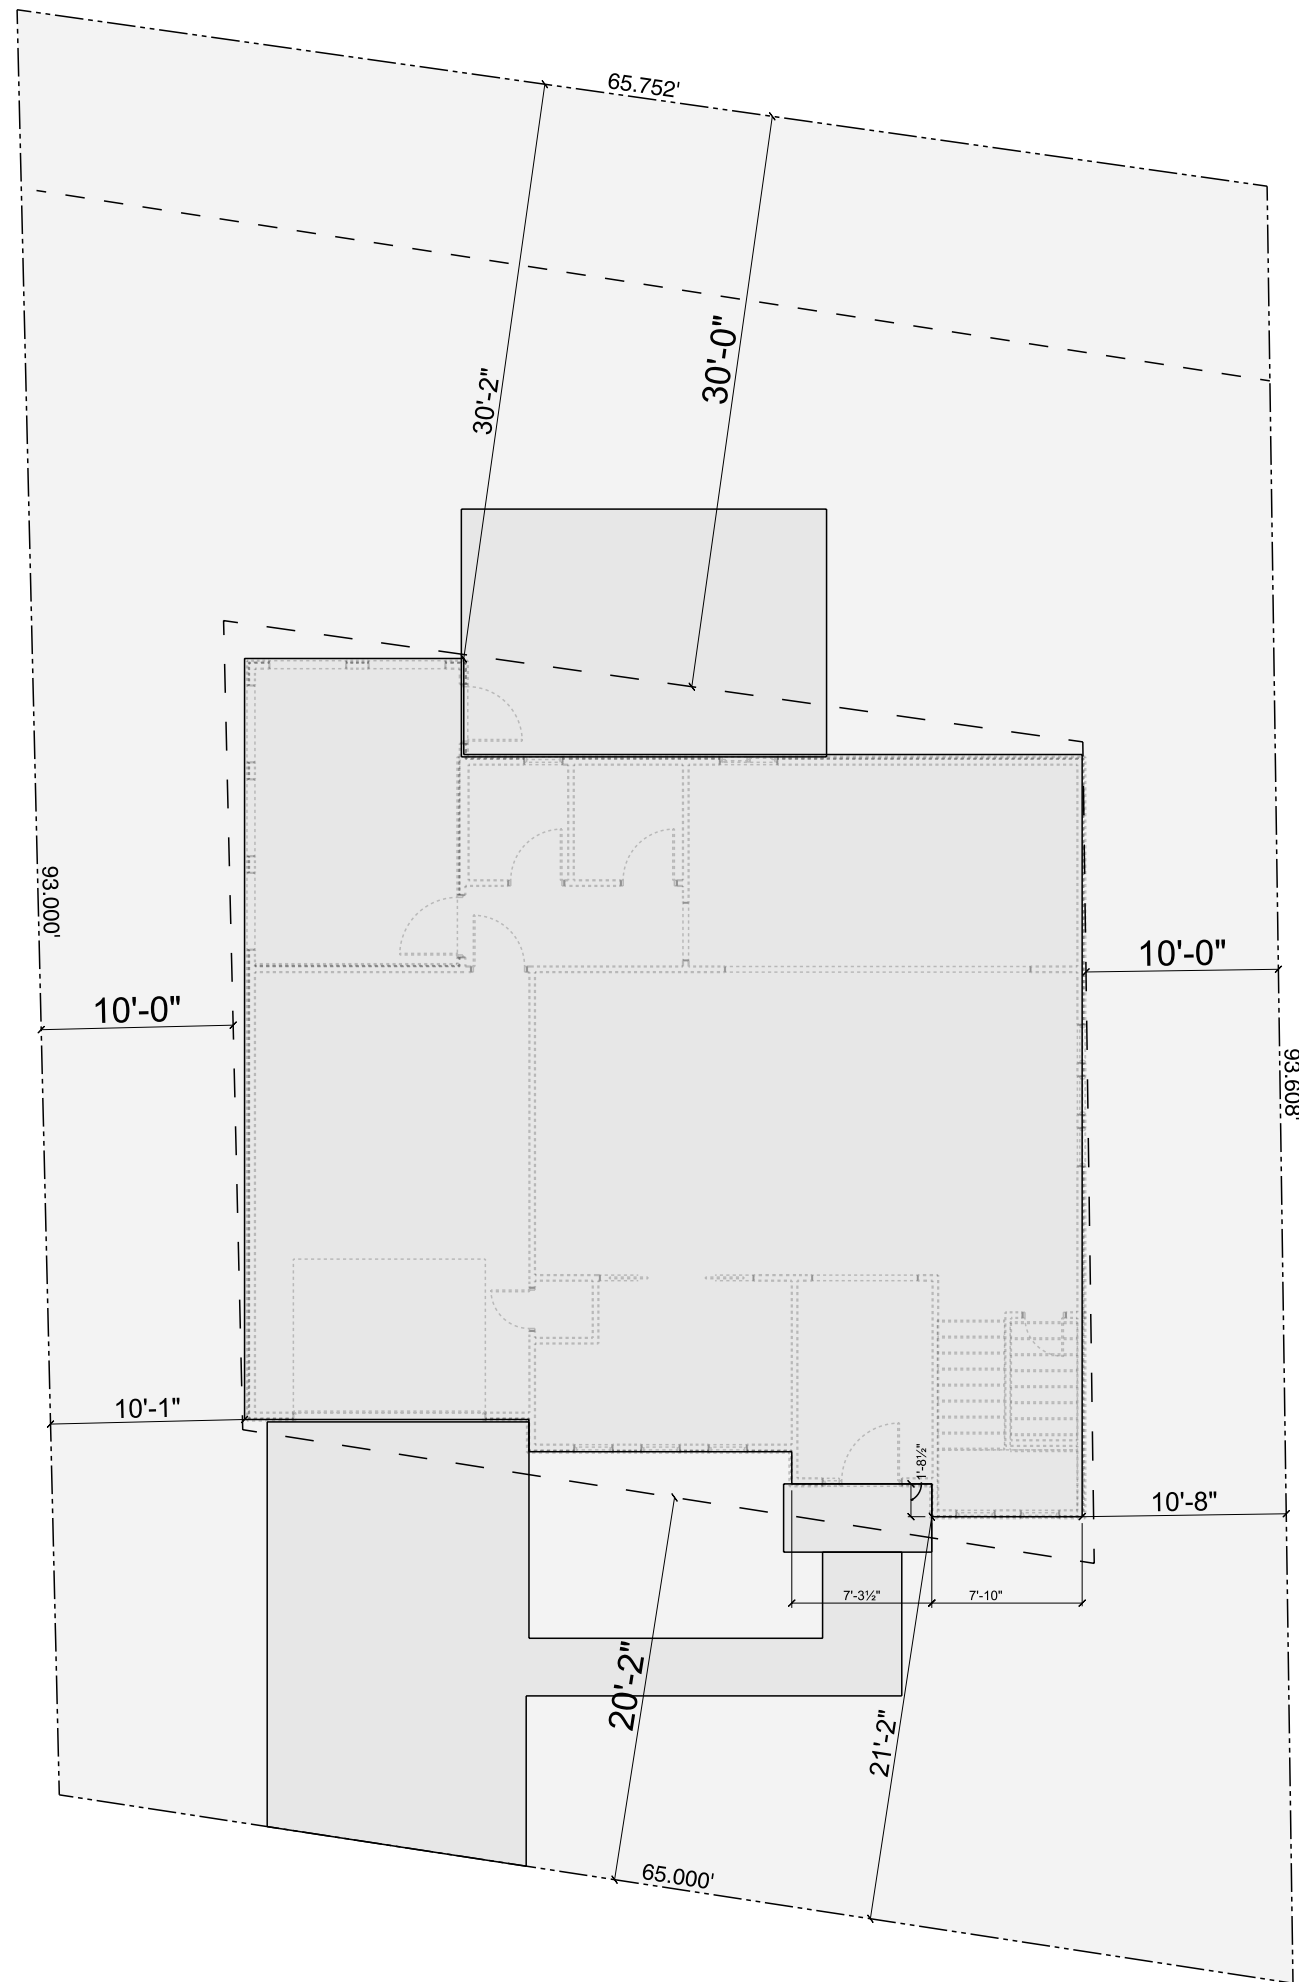

Plot Plan
SCALE: 1" = 10'-0"



The purchaser of these plans assumes all responsibility for their accuracy including verification of all dimensions, compliance with any and all governing codes, ordinances and covenants having jurisdiction over the site of construction and determining any modifications necessary to meet actual site conditions. If changes or modifications are necessary or desired, only persons qualified to make such changes should be consulted (i.e. Professional Engineer, Architect, Building Designer or Building Contractor). VHD assumes no liability for any home constructed from these plans.

The purchase of these plans share full ownership of the house design illustrated in these drawings with VHD and has all rights to these plans. These plans can be used, reproduced, sold and/or assigned to a third party at the purchaser's or VHD's discretions.




AREA SCHEDULE	
NAME	AREA
Heated	
1st Floor Heated	1125 sq ft.
2nd Floor Heated	1420 sq ft.
Total Heated	2545 sq ft.
UnHeated	
Garage	343 sq ft.
Screened Porch	188 sq ft.
Total UnHeated	531 sq ft.
Total	3076 sq ft.

DRAWING SCHEDULE	
Cover - Plot	1
Site Plan	2
Foundation & Roof Plan	3
Floor Plan	4
Elevations	5
Electrical Plans	6
Cross Sections	7
Plumbing Drops & Centerings	8

OPENING ID	WIDTH	HEIGHT	TYPE	HINGE	COUNT
1	2'-0"	4'-0"	WINDOW	N	1
2	3'-0"	3'-6"	SLIDING WINDOW	NL	1
3	2'-0"	6'-0"	WINDOW	N	5
4	2'-0"	6'-0"	WINDOW	N	1
5	2'-0"	5'-0"	WINDOW	N	1
6	2'-0"	5'-0"	WINDOW	N	1
7	4'-0"	4'-0"	WINDOW	N	1
8	4'-0"	5'-0"	WINDOW	N	1
9	4'-0"	5'-0"	WINDOW	N	1
10	4'-0"	5'-0"	WINDOW	N	1
11	4'-0"	5'-0"	WINDOW	N	1
12	3'-0"	1'-0"	WINDOW	N	1
13	3'-0"	4'-0"	WINDOW	N	1
14	2'-0"	1'-0"	WINDOW	N	2
16	2'-0"	4'-0"	WINDOW	N	2
18	3'-0"	5'-0"	WINDOW	U	4
19	3'-0"	1'-6"	WINDOW	N	1
A	2'-8"	6'-8"	DOOR	L	1
A	2'-8"	6'-8"	DOOR	R	4
B	4'-11 1/2"	8'-1 1/2"	COMBINED UNIT WITH DOOR	R	1
C	15'-11"	8'-0"	ARCH	N	1
D	2'-0"	6'-8"	DOOR	L	1
D	2'-0"	6'-8"	DOOR	R	2
E	3'-0"	6'-8"	ARCH	N	2
F	4'-0"	8'-0"	COMBINED UNIT WITH DOOR	NN	1
G	5'-6"	8'-0"	ARCH	N	1
H	4'-0"	7'-0"	ARCH	N	1
I	4'-0"	7'-0"	ARCH	N	1
J	4'-0"	7'-0"	ARCH	N	1
K	4'-0"	7'-0"	ARCH	N	1
L	4'-0"	7'-0"	ARCH	N	1
M	2'-10"	8'-0"	DOOR	L	1
N	10'-0"	8'-0"	GARAGE	U	1
O	3'-0"	6'-8"	DOOR	R	1
P	5'-0"	6'-8"	SLIDING DOOR	NN	1
Q	2'-6"	6'-8"	DOOR	L	3
Q	2'-6"	6'-8"	DOOR	R	2
R	4'-0"	6'-8"	SLIDING DOOR	NN	1
S	2'-6"	6'-8"	DOOR	L	1
T	1'-5"	2'-6"	NICHE	N	1
U	2'-1"	6'-8"	SLIDING BARN DOOR	L	1
V	2'-0"	3'-6"	NICHE	N	1
W	3'-0"	6'-8"	SLIDING BARN DOOR	L	1


AREA SCHEDULE	
NAME	AREA
Heated	
1st Floor Heated	1125 sq ft.
2nd Floor Heated	1420 sq ft.
Total Heated	2545 sq ft.
UnHeated	
Garage	343 sq ft.
Screened Porch	188 sq ft.
Total UnHeated	531 sq ft.
Total	3076 sq ft.

KEYNOTE SCHEDULE	
ID	NOTE
①	Dishwasher
②	Oven/Range & Hood
③	Refrigerator
④	Washer & Dryer
⑤	Standing Tub

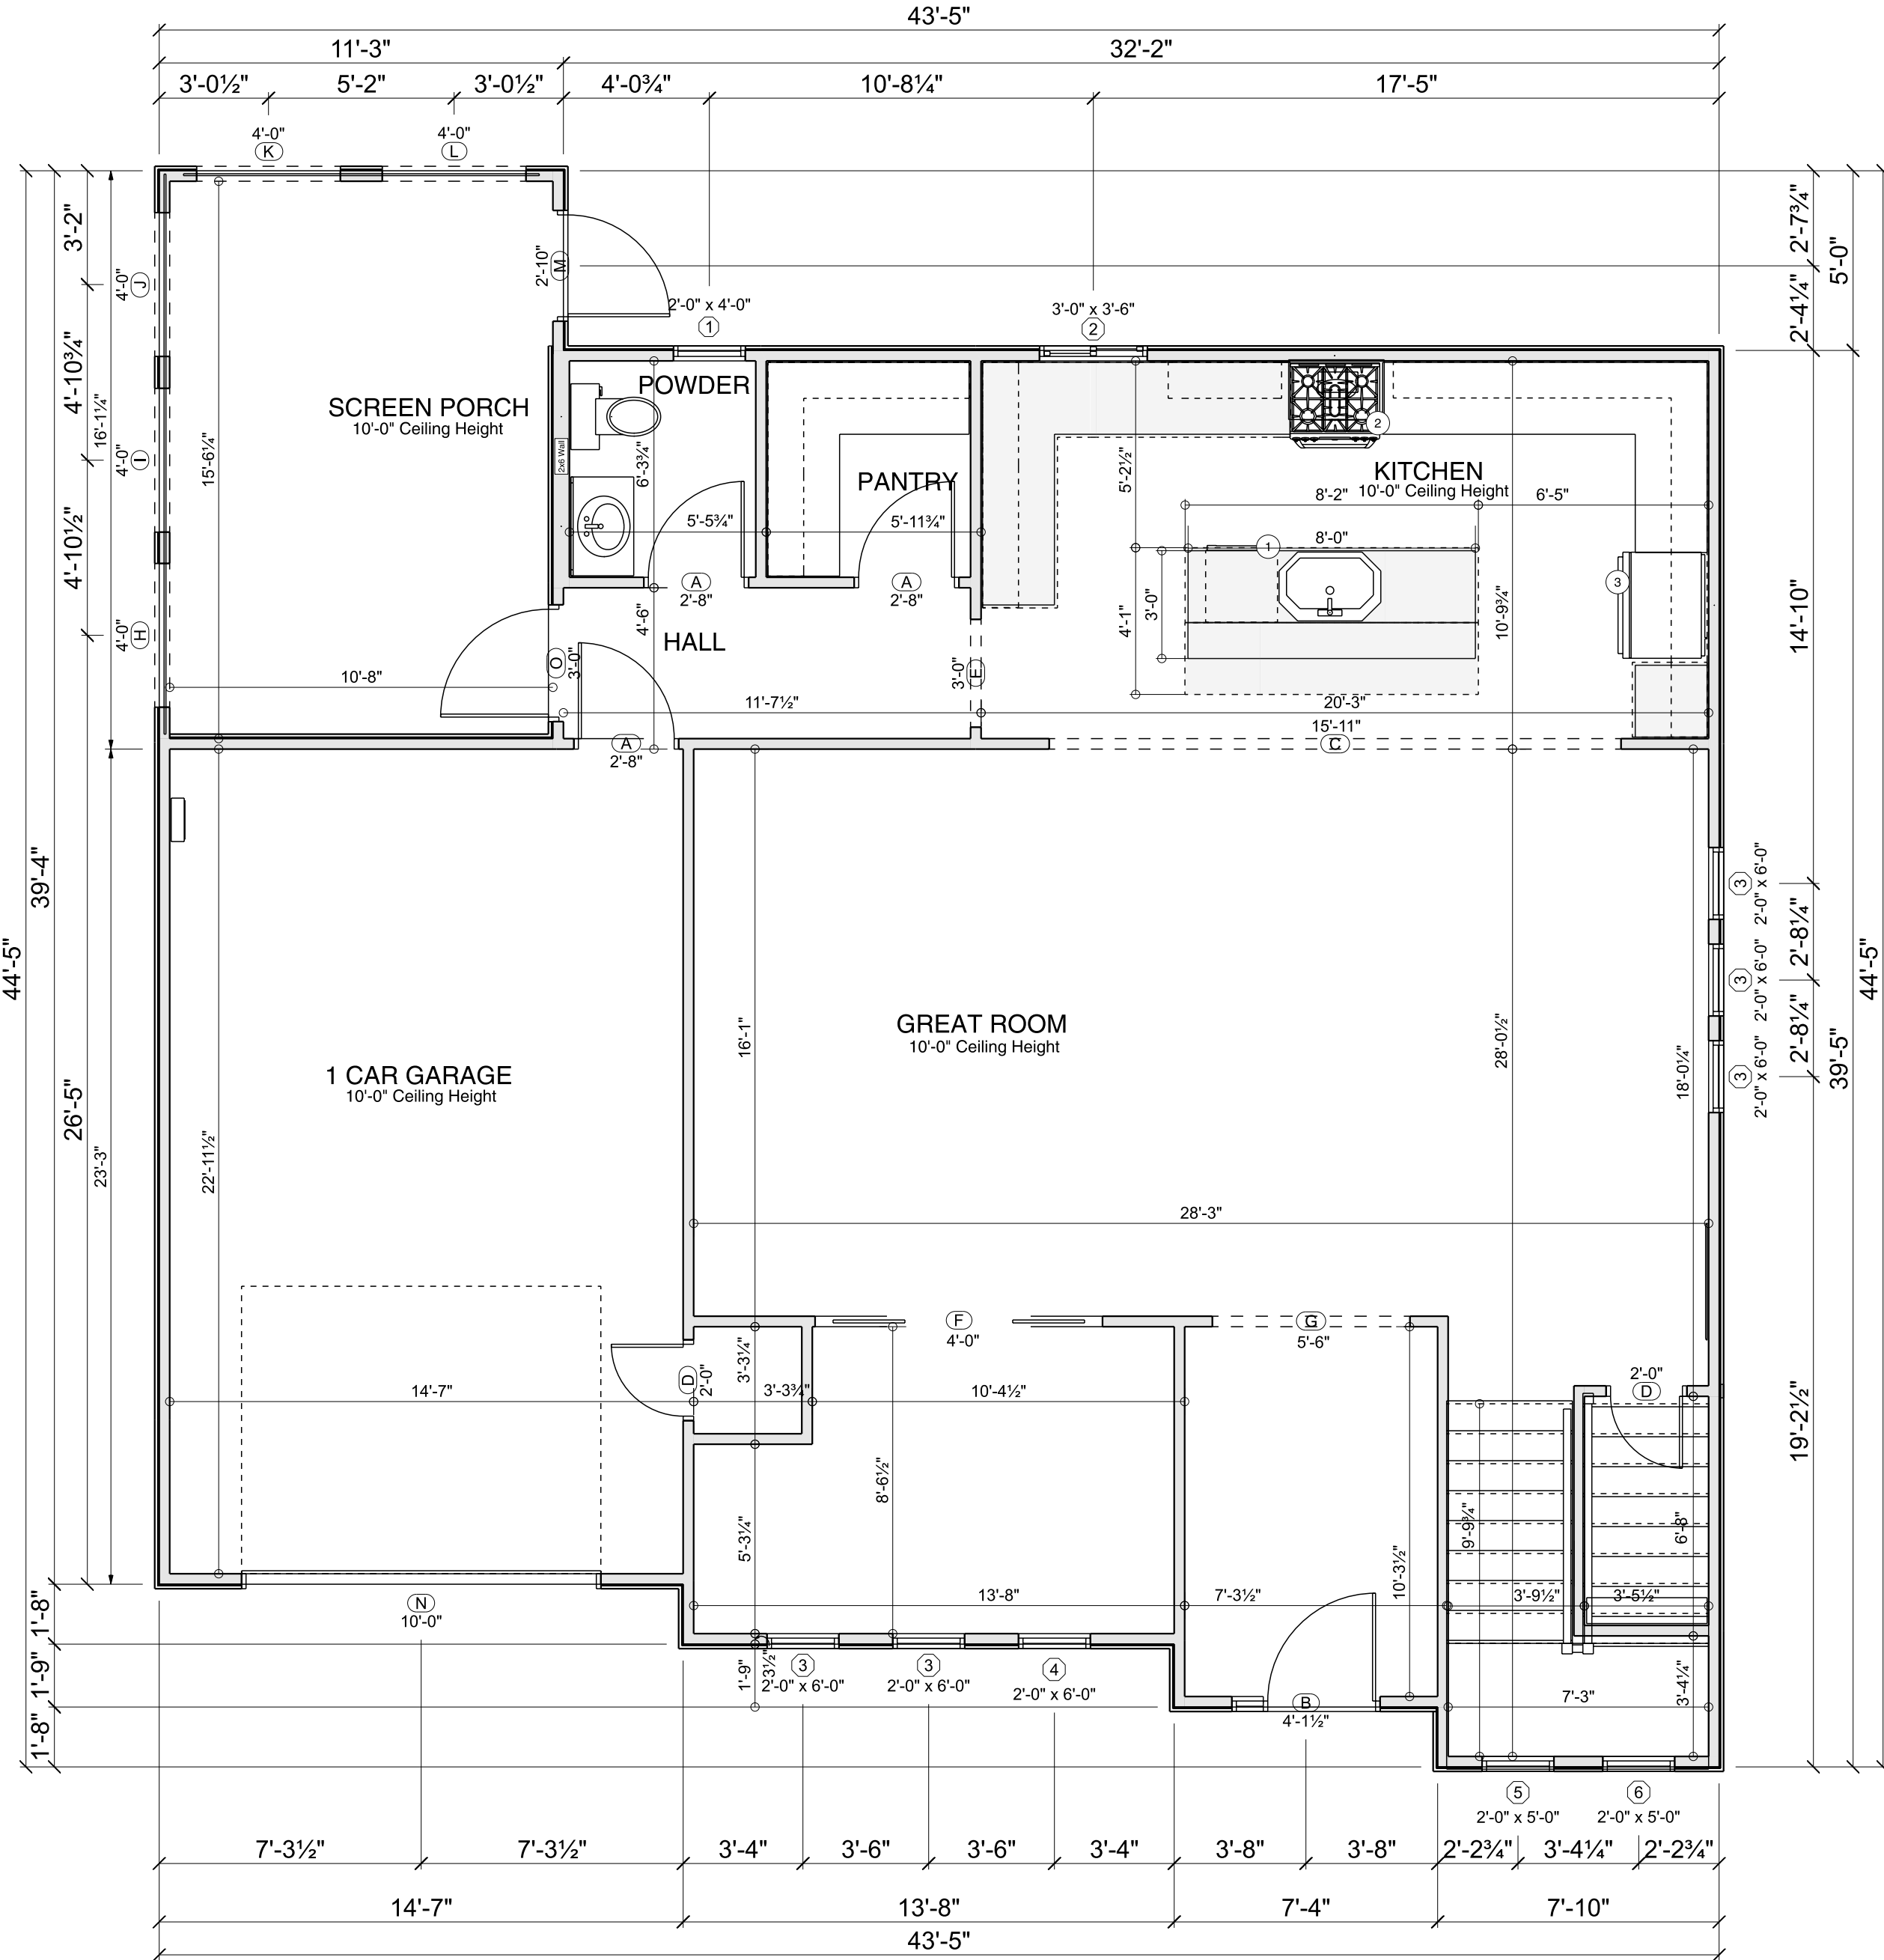

Main Floor

SCALE: 1/4" = 1'-0"

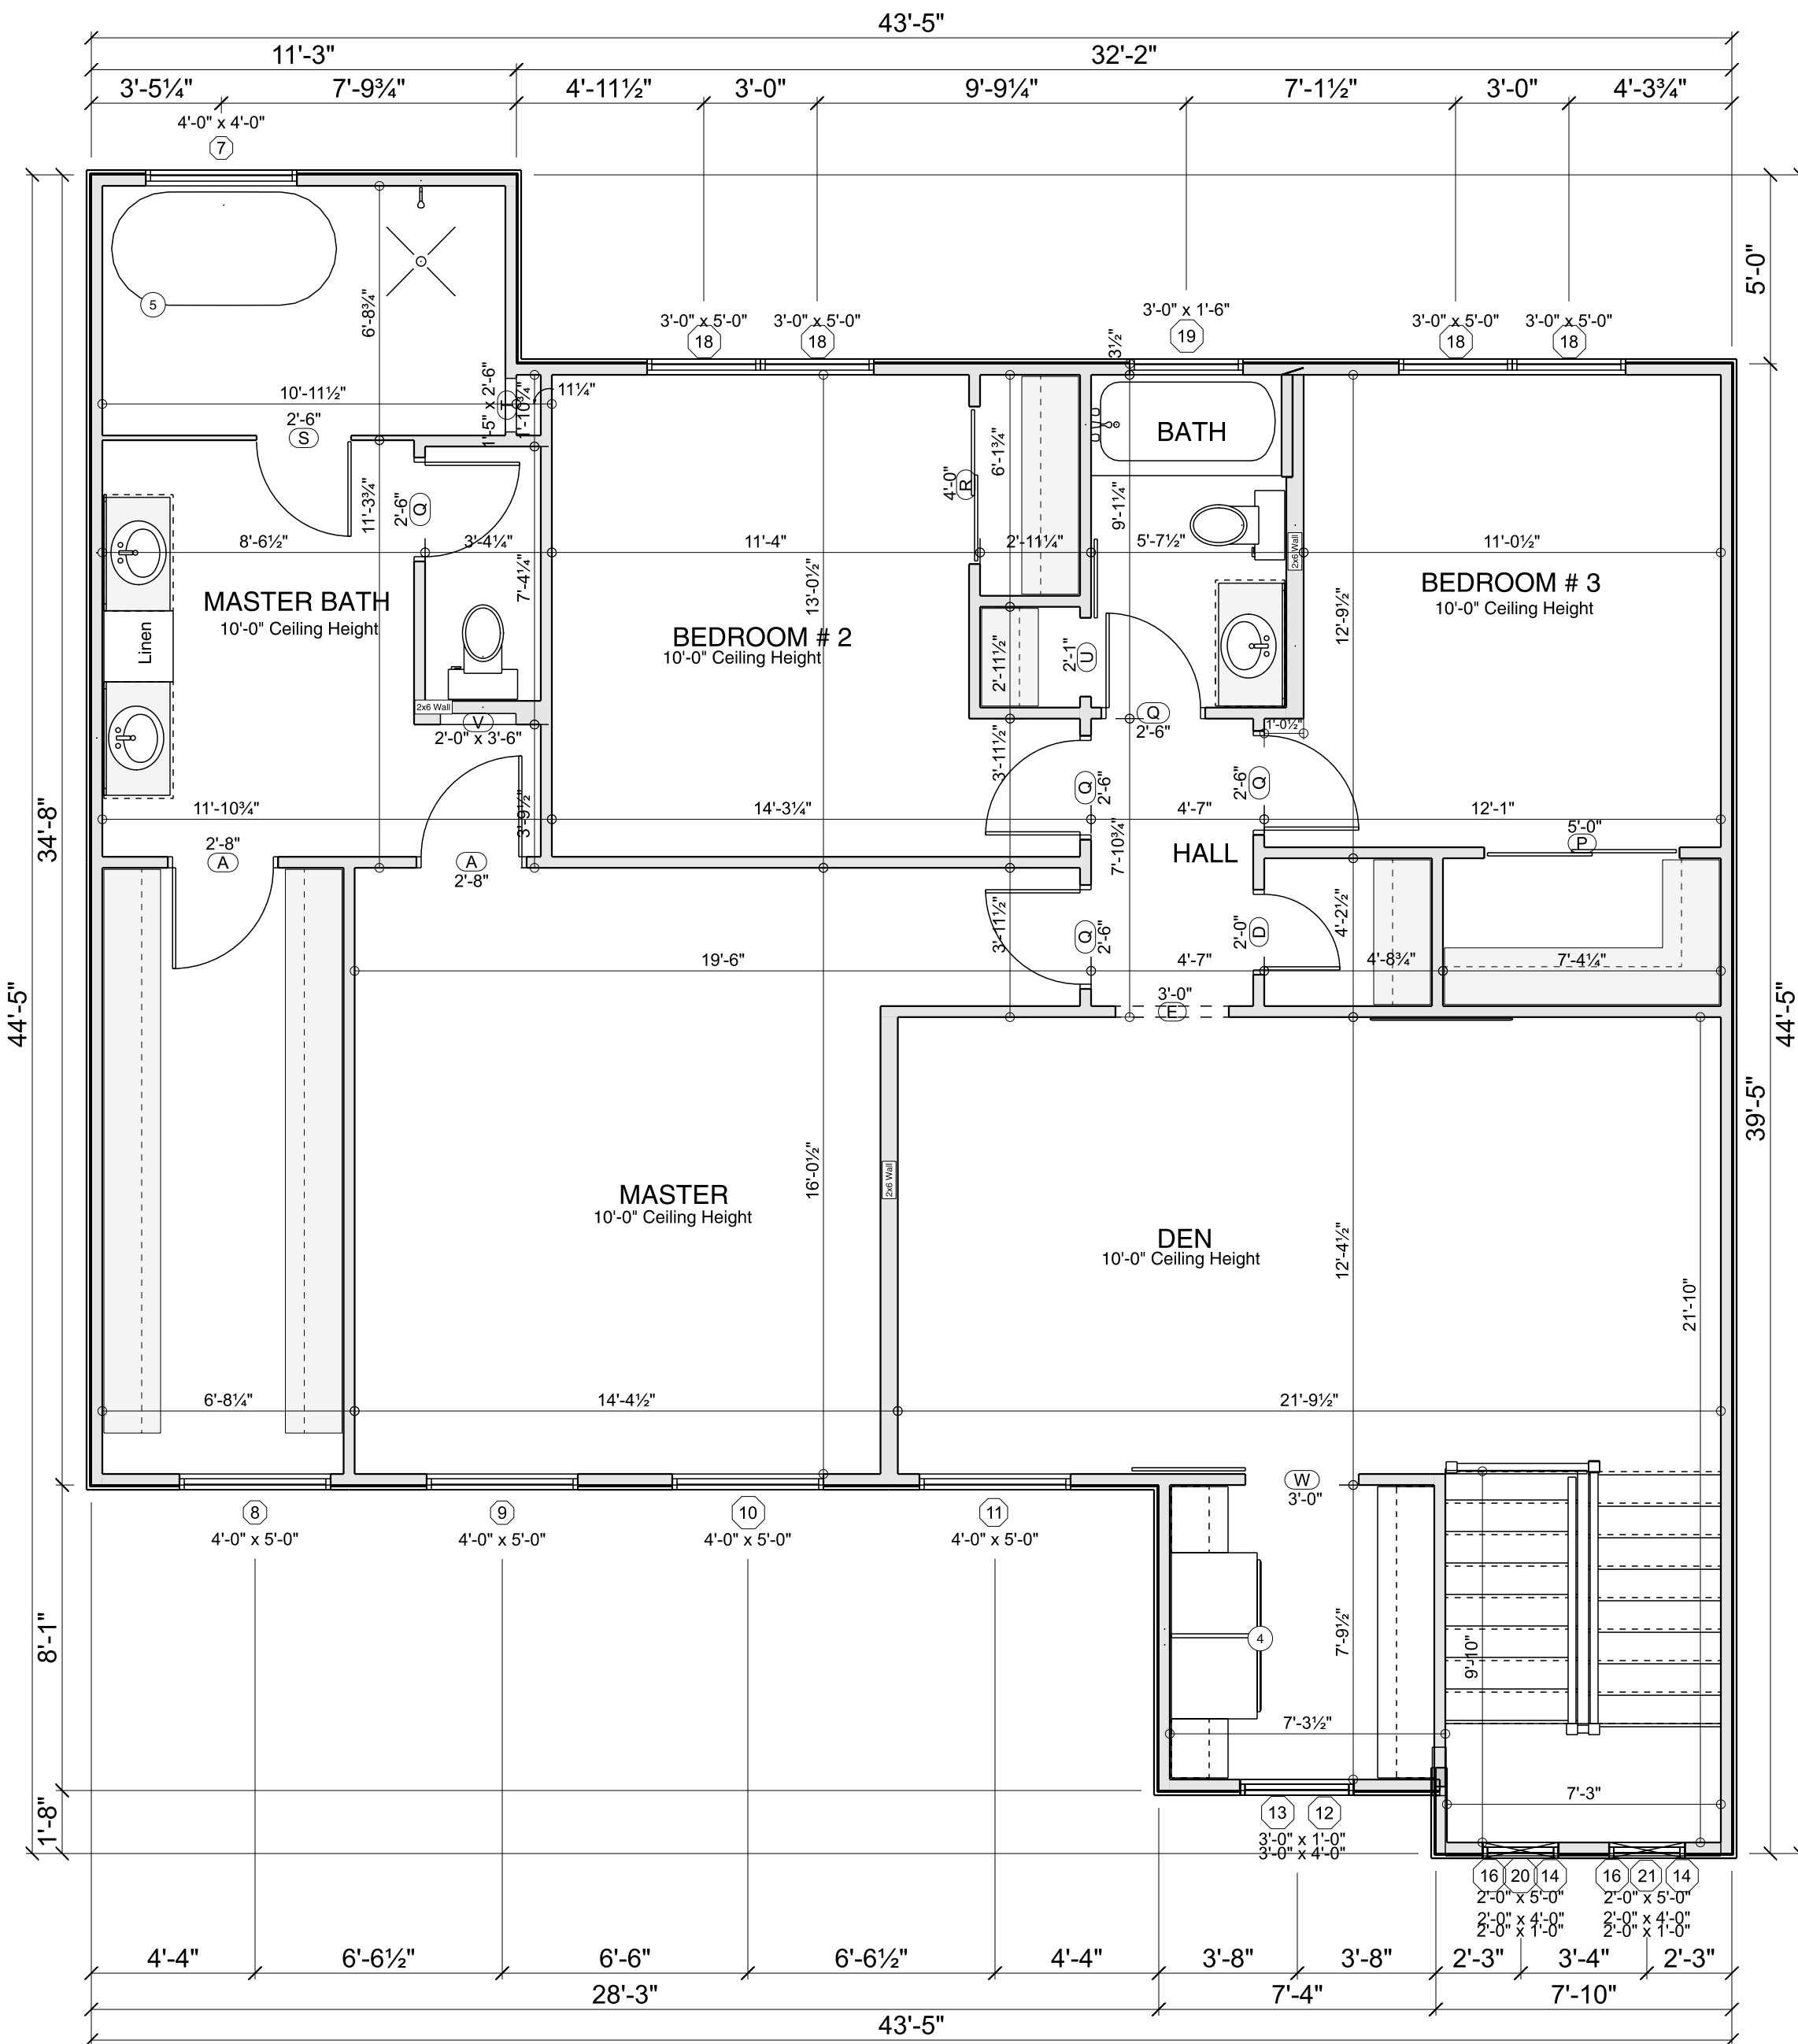


2nd Floor

SCALE: 1/4" = 1'-0"



Front Elevation

SCALE: 1/4" = 1'-0"

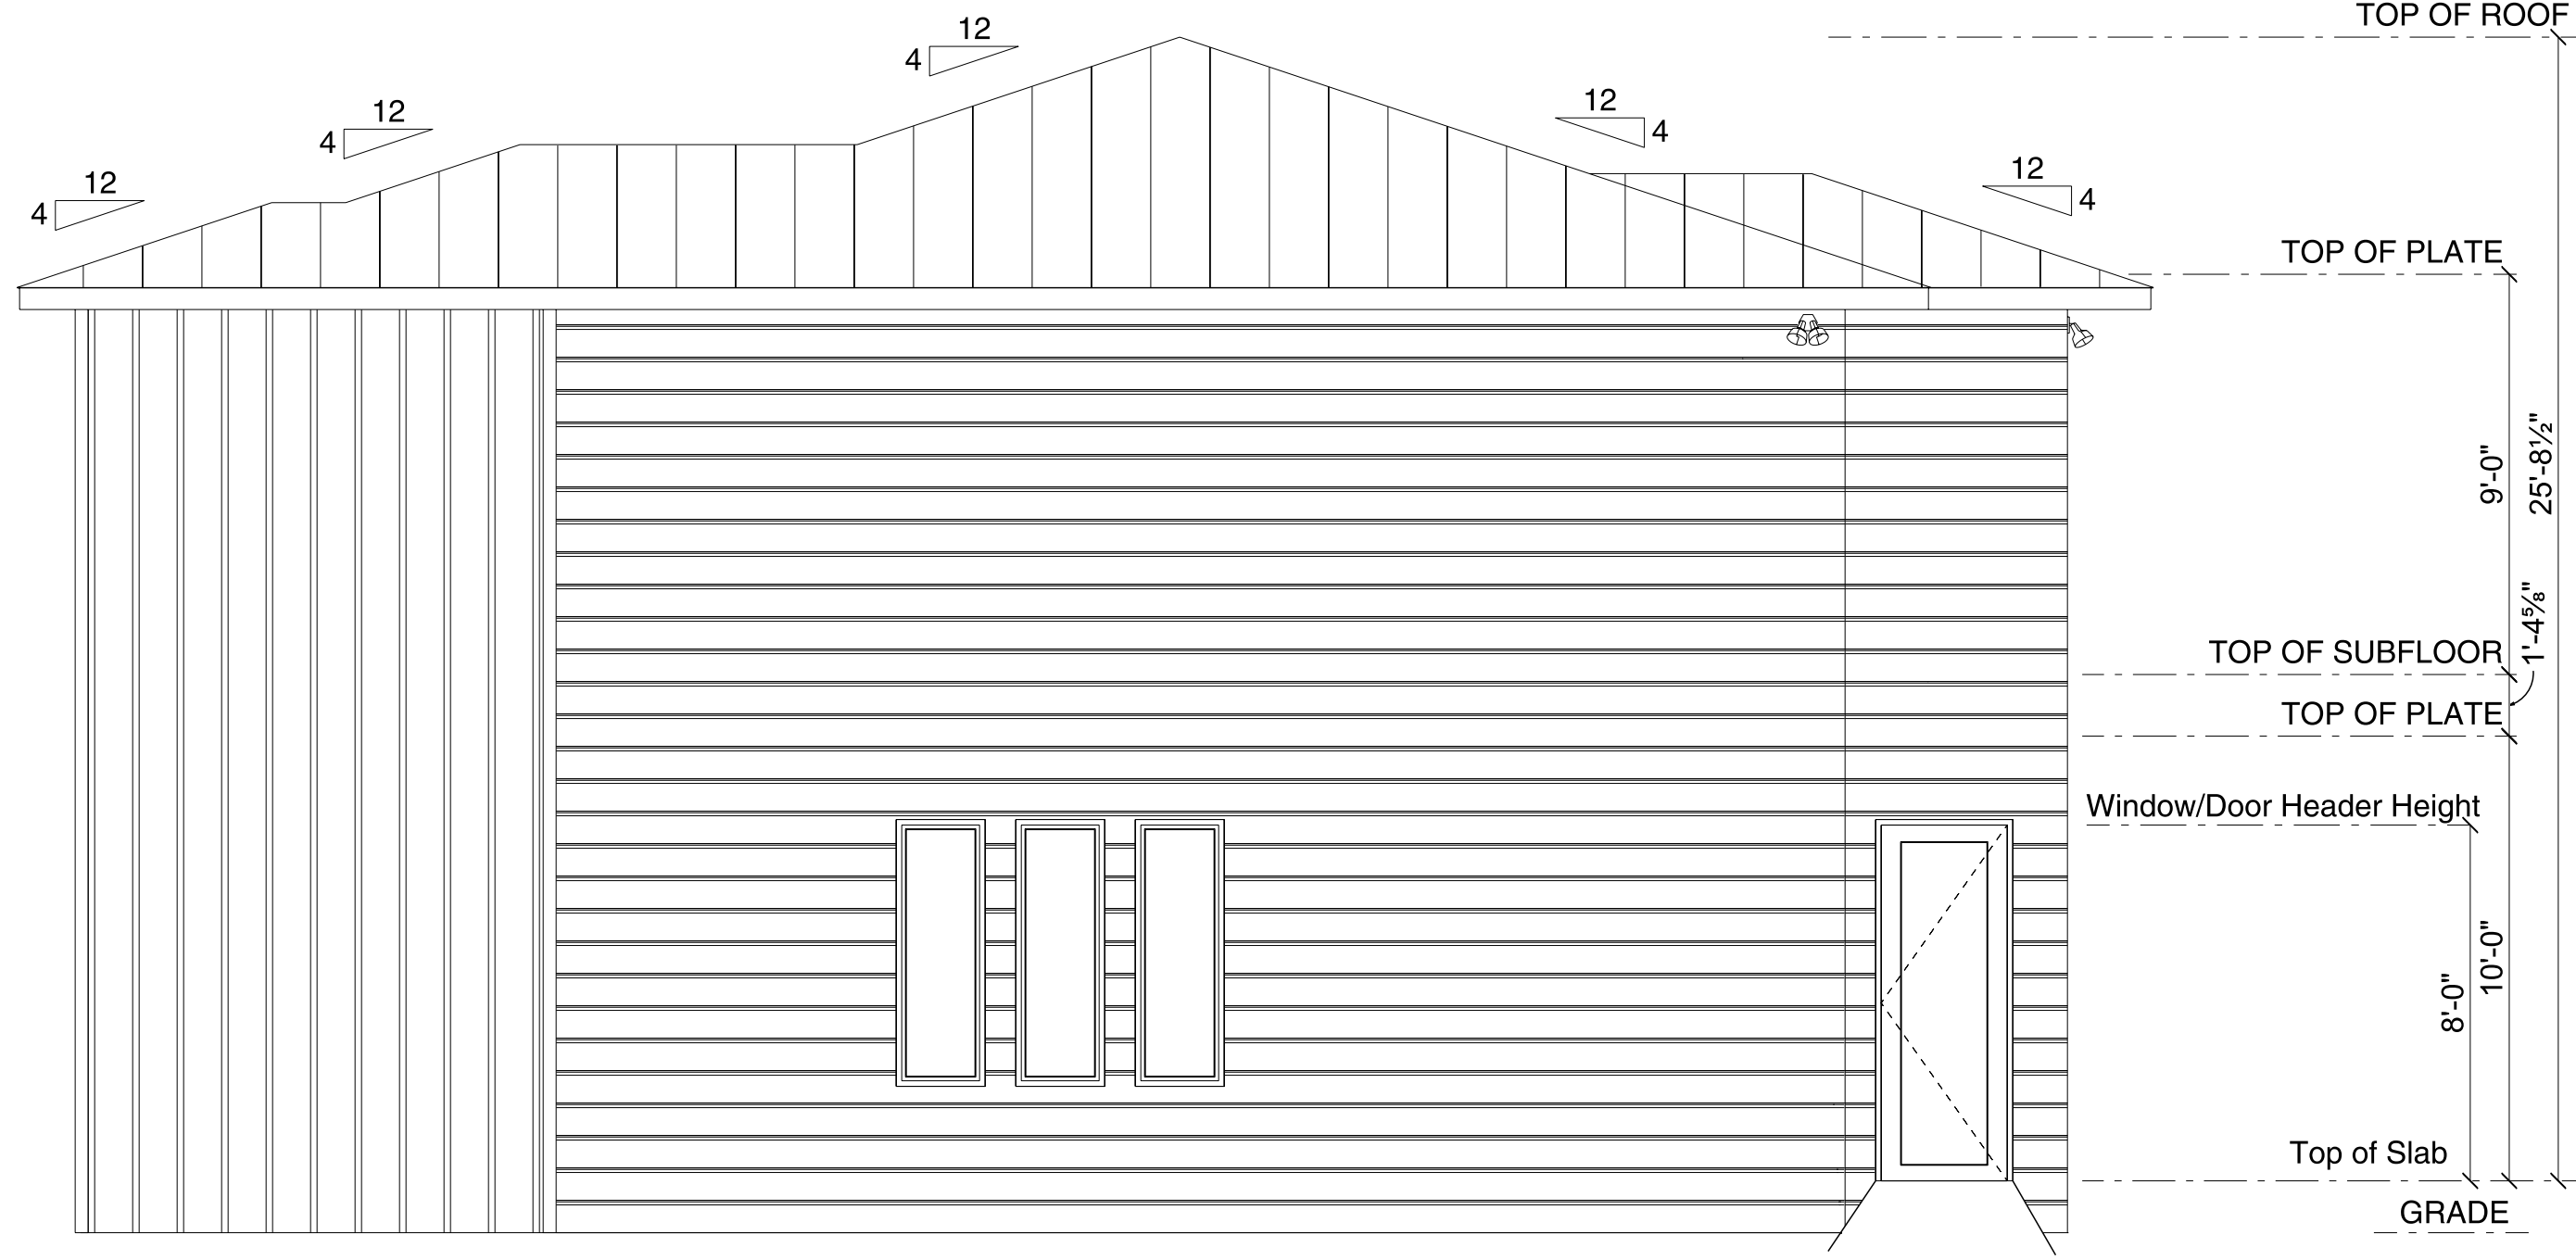


Right Elevation

SCALE: 1/4" = 1'-0"



Rear Elevation

SCALE: 1/4" = 1'-0"

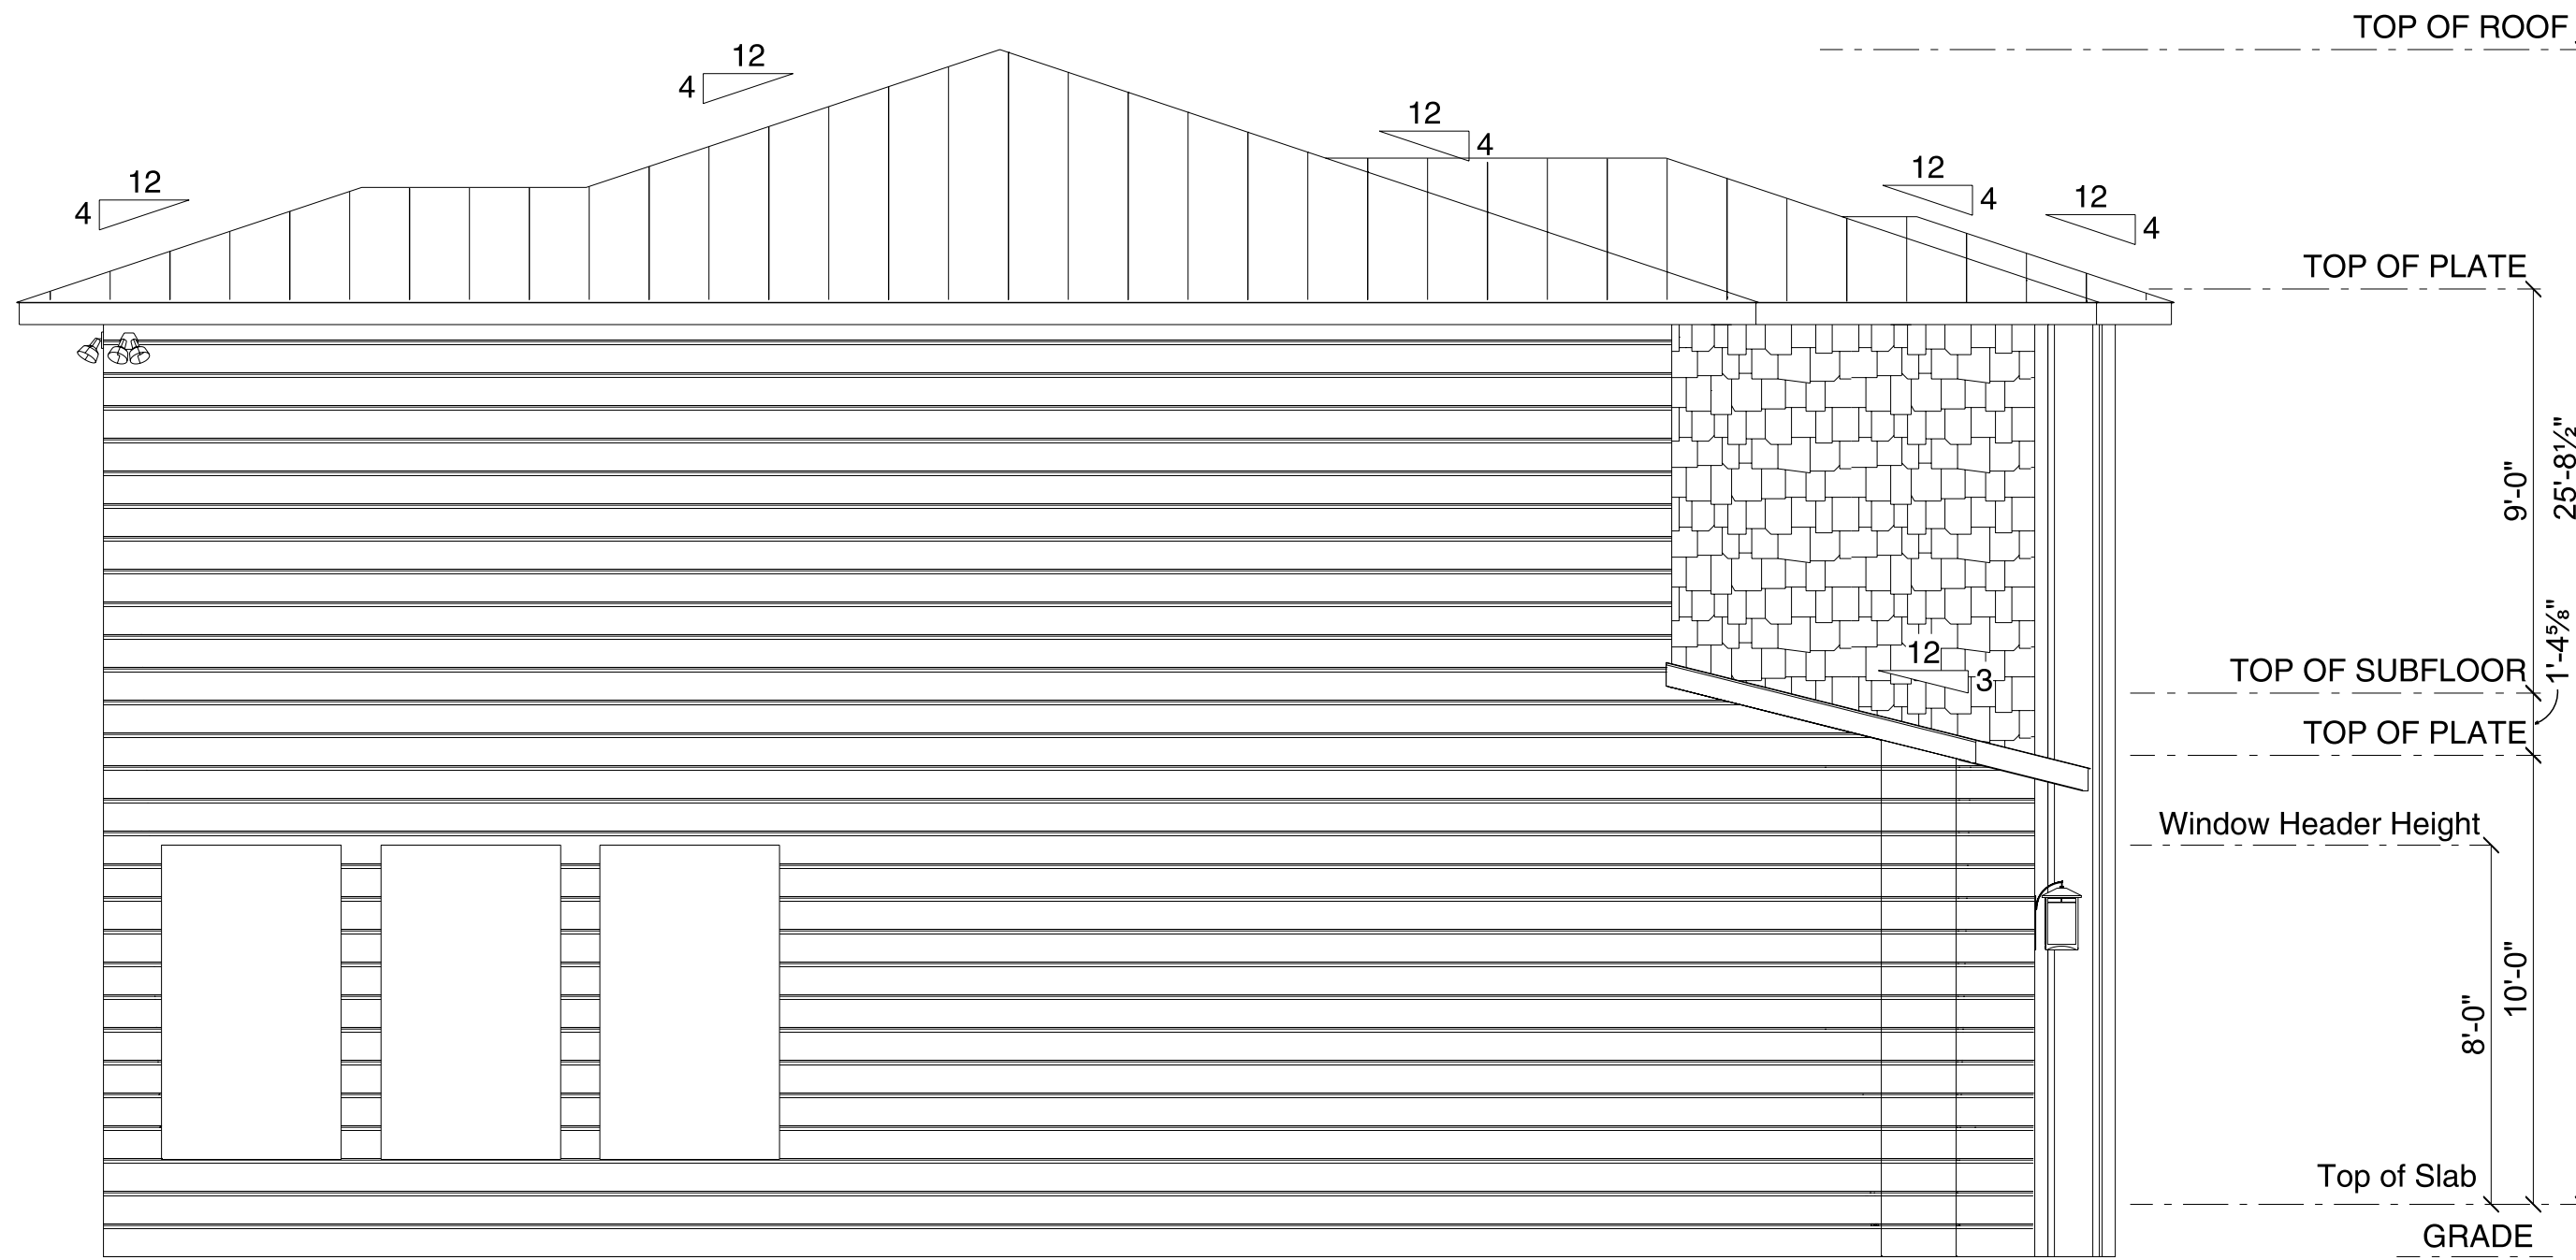

Left Elevation

SCALE: 1/4" = 1'-0"